


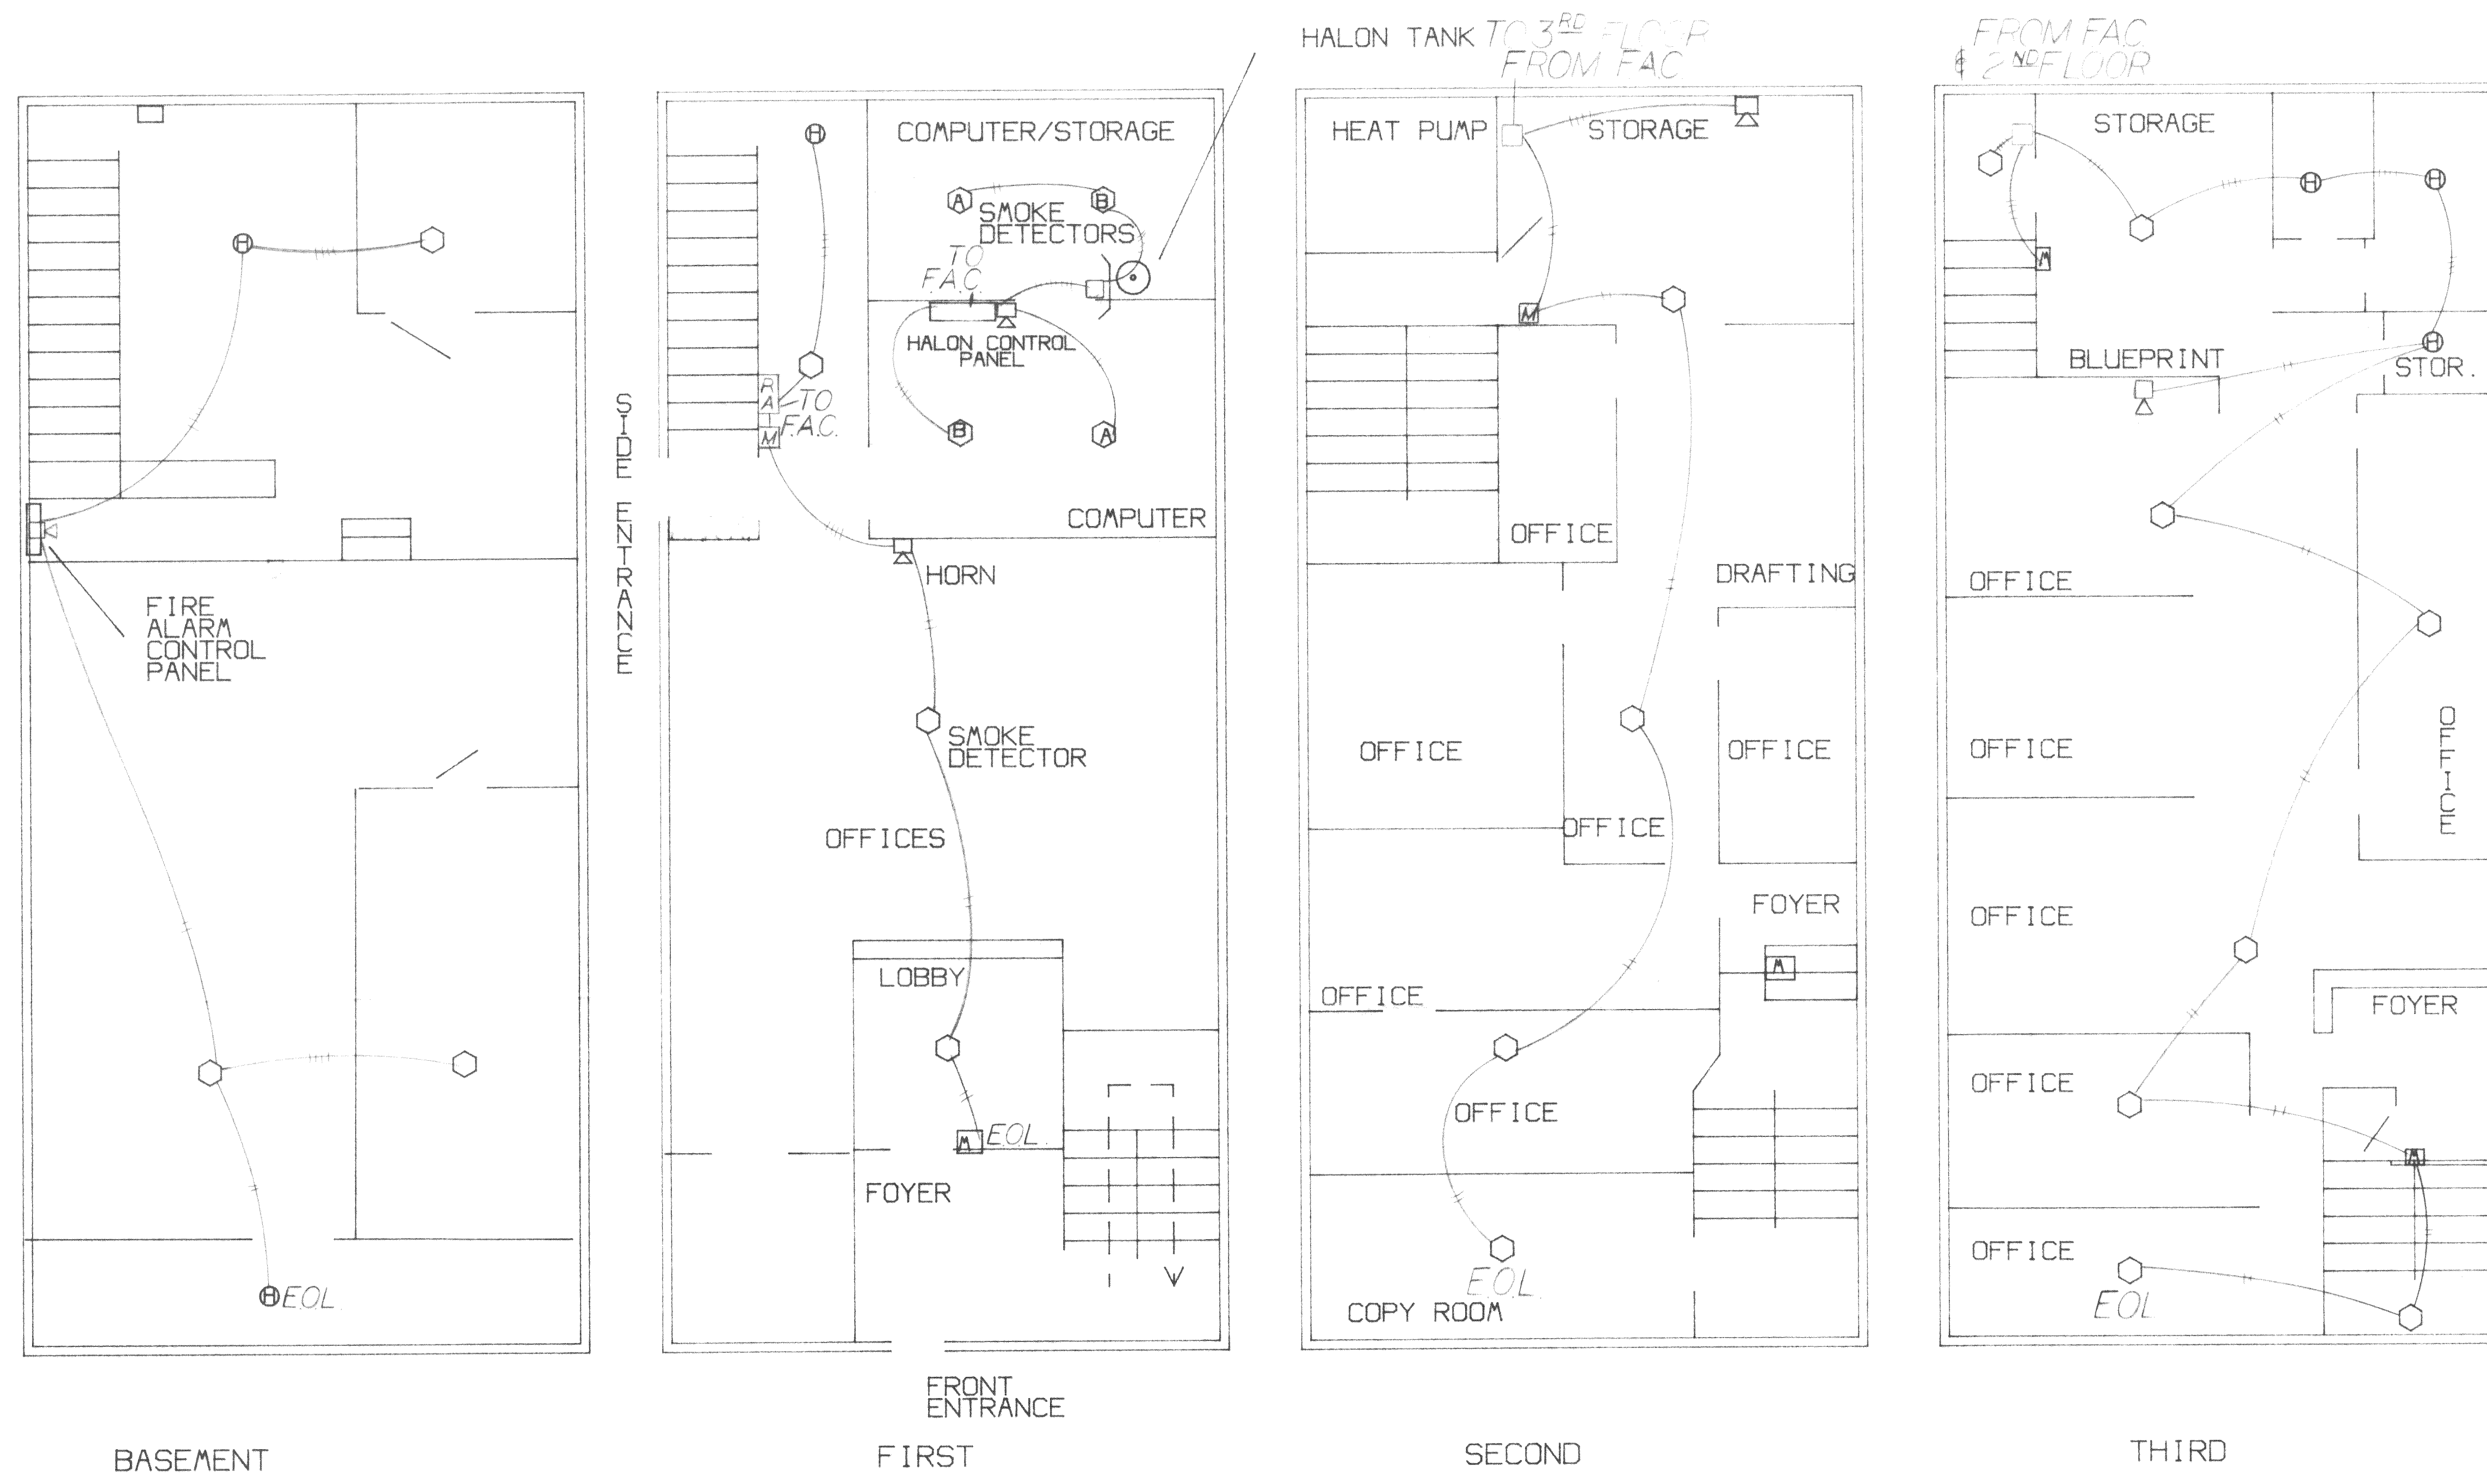

| ROOM  | FT. 2 | HGT. | FT. 3 | TEMP. | O/O | HALON | LEAK | TOT. HAL. | NOZZLE |
|-------|-------|------|-------|-------|-----|-------|------|-----------|--------|
| COMP. | 251.8 | 8.83 | 2223  | 70    | 6   | 55.5  | .5   | 56        | N1     |
| STOR. | 209.0 | 8    | 1672  | 70    | 6   | 41.6  | .4   | 42        | N2     |

TOTAL HALON 98LBS.



| A | REV. | DATE | REVISION | INIT. |
|---|------|------|----------|-------|
|   |      |      |          |       |

GENERAL FIRE PROTECTION SYSTEMS, INC.  
A SUBSIDIARY OF GENERAL FIRE EQUIPMENT COMPANY  
E. 4804 TRENT AVE.  
SPOKANE, VA. 99202  
1-509-535-4255

TITLE: ELLENSBURG CITY HALL  
HALON 1301+ FIRE ALARM SYSTEMS

DRAWING #: 11946  
CADD REF.: ELCHALL

DATE: 11-1-89  
PROJECT MANAGER: MILLER  
SHEET 1 OF 1

SCALE: N.T.S.